
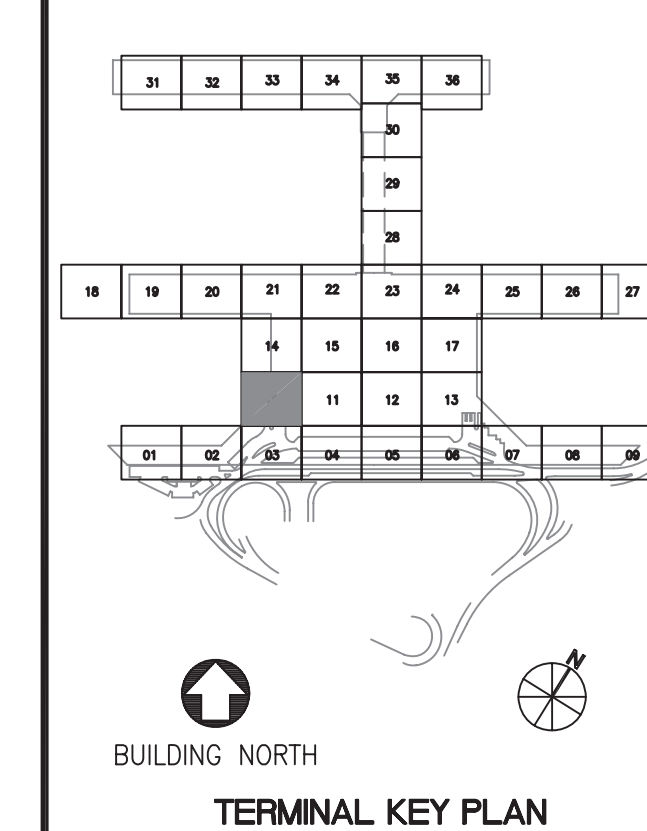


NOTES:
1. CLEAN OUT TEES 18" ABOVE
FLOOR ON ALL STORM DRAIN
STACKS

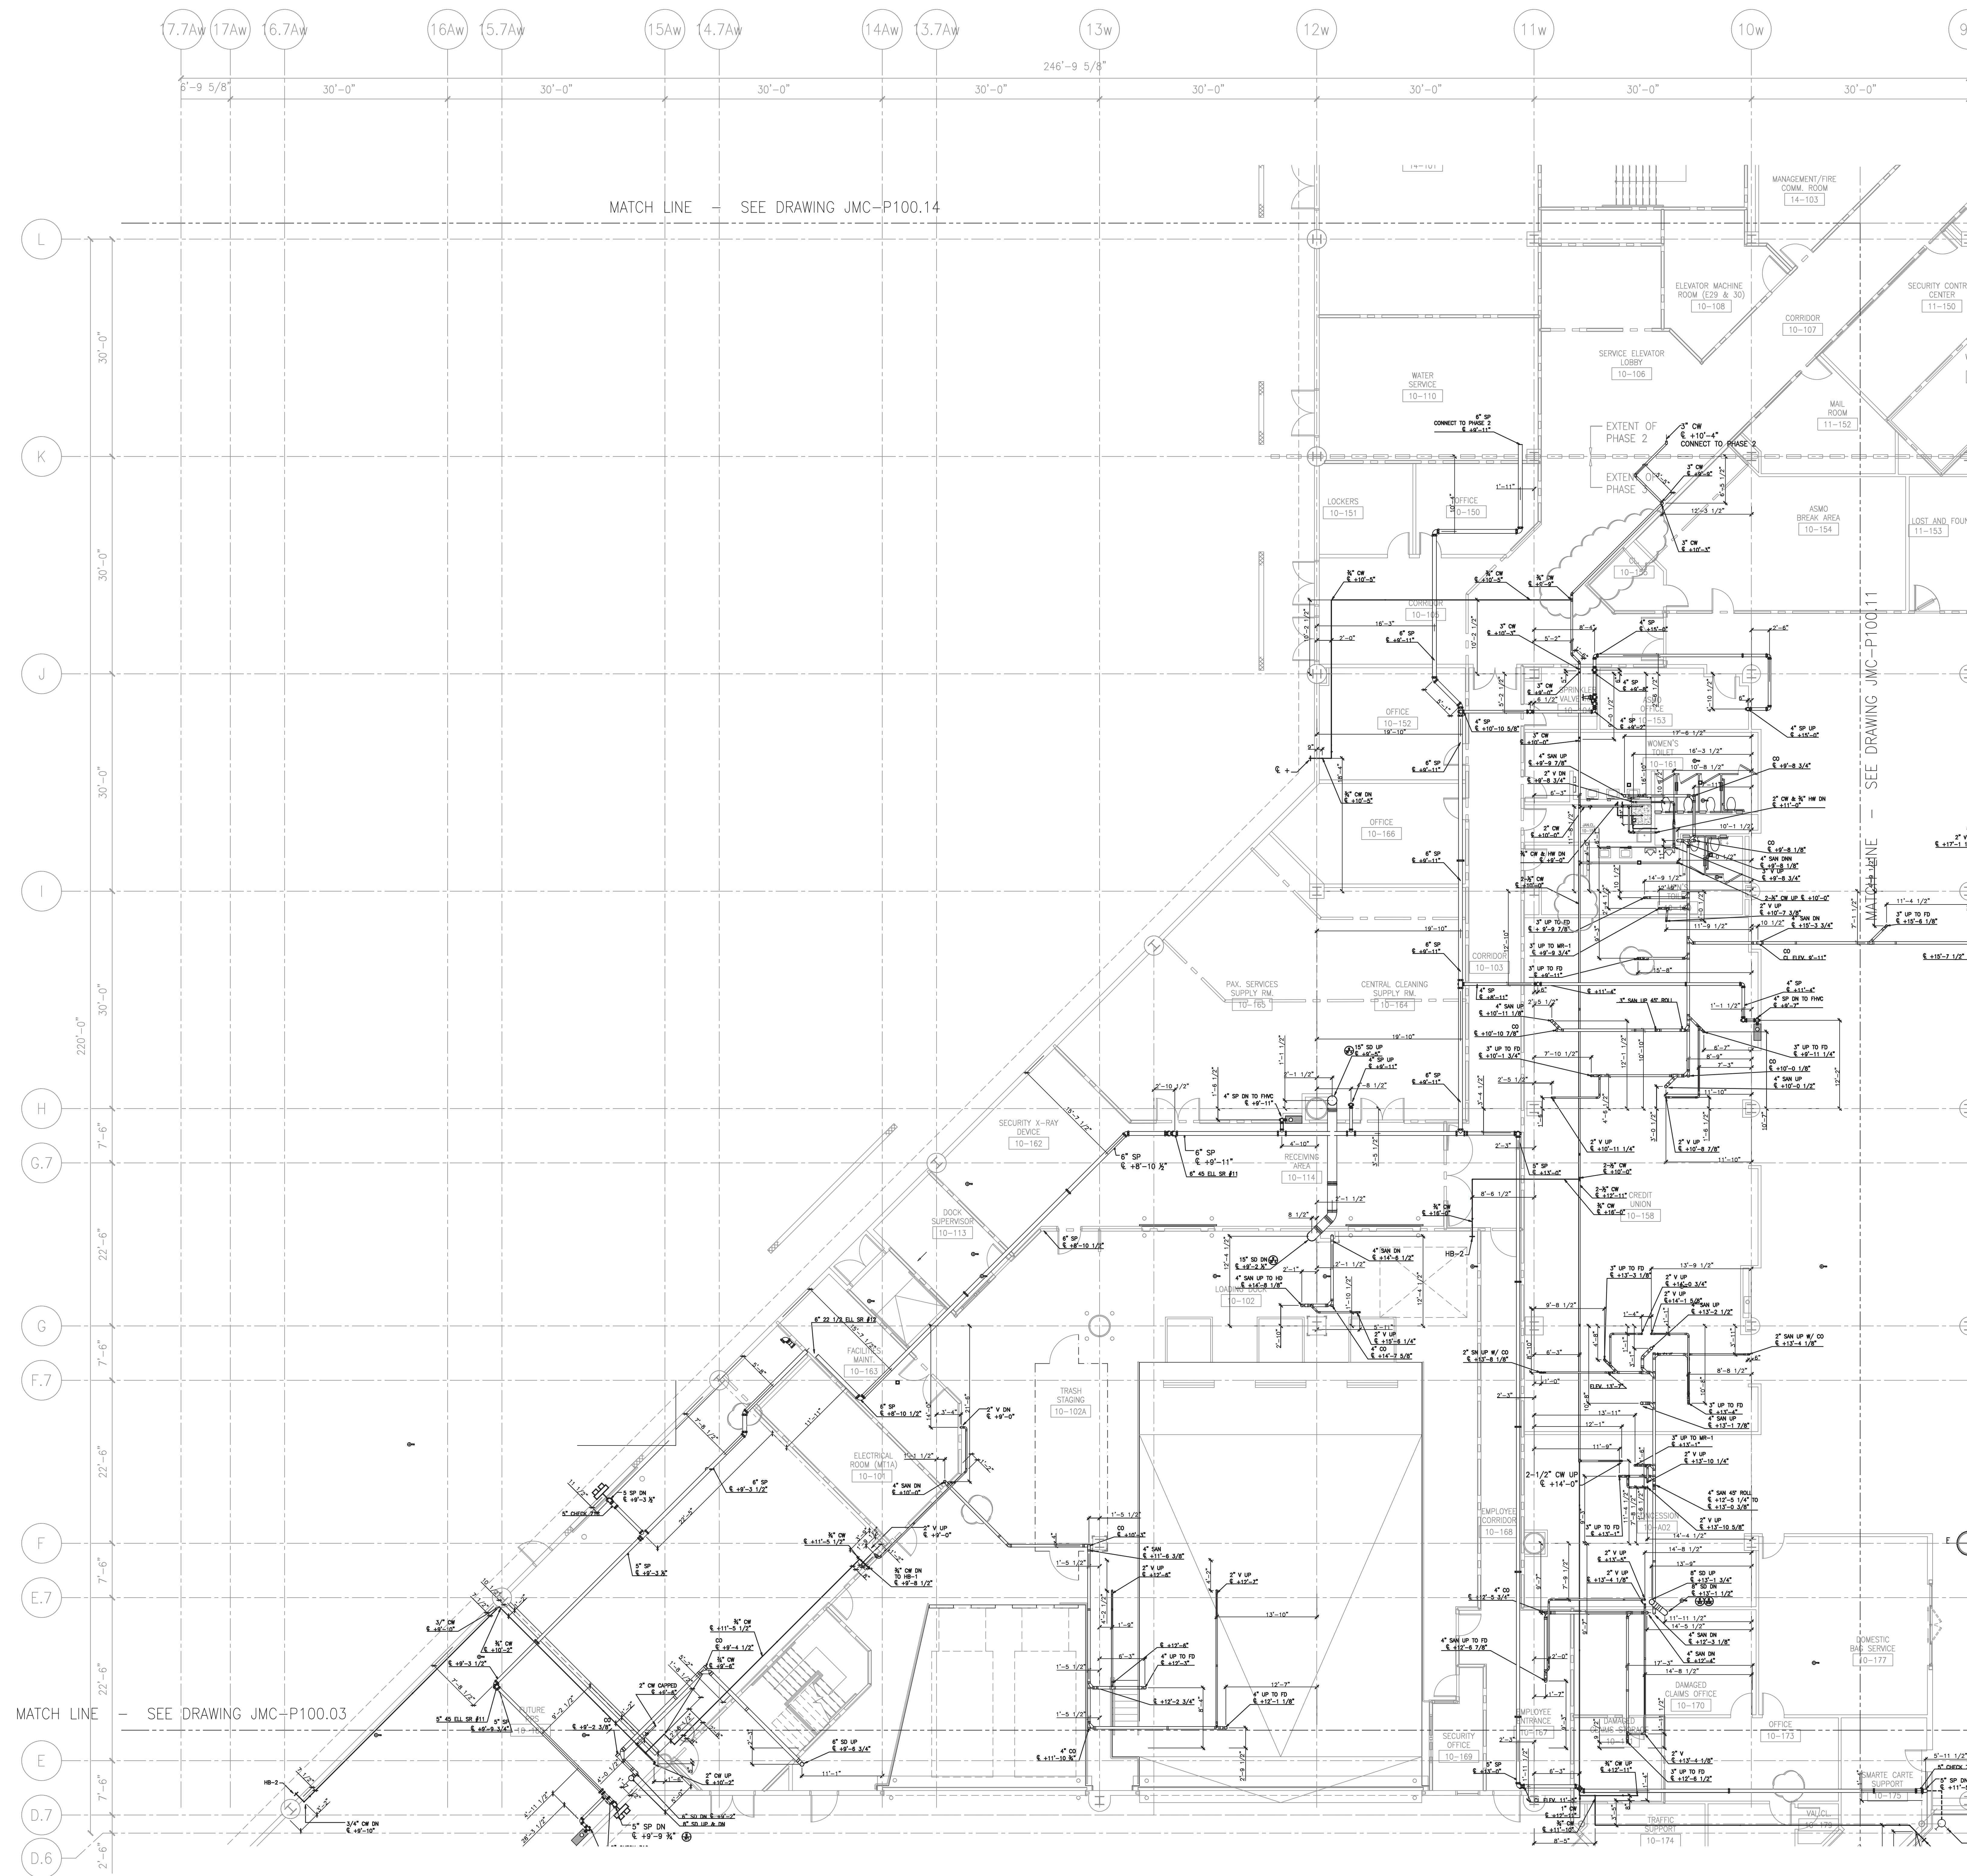

Rev.	Date	Description	Project Addendum
2	4/30/07	TS-3 CHANGES	
1	12/12/06	TS-2 CHANGES	

PHASE 3 - 1571-15150
P-100.10-003
AMERICAN AIR LINES
JFK TERMINAL REDEVELOPMENT
REVIEWED
THIS DRAWING IS MADE FOR OFFICE
CONVENIENCE ONLY. THE USER
HEREBY ASSUMES ALL LIABILITY FOR
ANY ERRORS OR OMISSIONS. THE
DESIGNER DOES NOT ASSUME
ANY RESPONSIBILITY FOR SUCH ITEMS
AS: CALCULATIONS, CODES, COMPLIANCE, ETC.
DATE: _____
BY: _____
CHECKED BY: _____
A JPM VENTURE

PLUMBING
EXPOSED PIPING
FIRST FLOOR PLAN
MAIN TERMINAL
AREA 10

Drawn by:
DM
Date:
2/3/06
Scale:
1/8" = 1'-0"

Sheet No.
JMC
P100.10

