


NOTES

-

NO	DR	REVISION	DATE
1	DM	AS PER REV C APRIL 2006	4/17/06
2	DM	AS PER REV D APRIL 2006	4/17/06

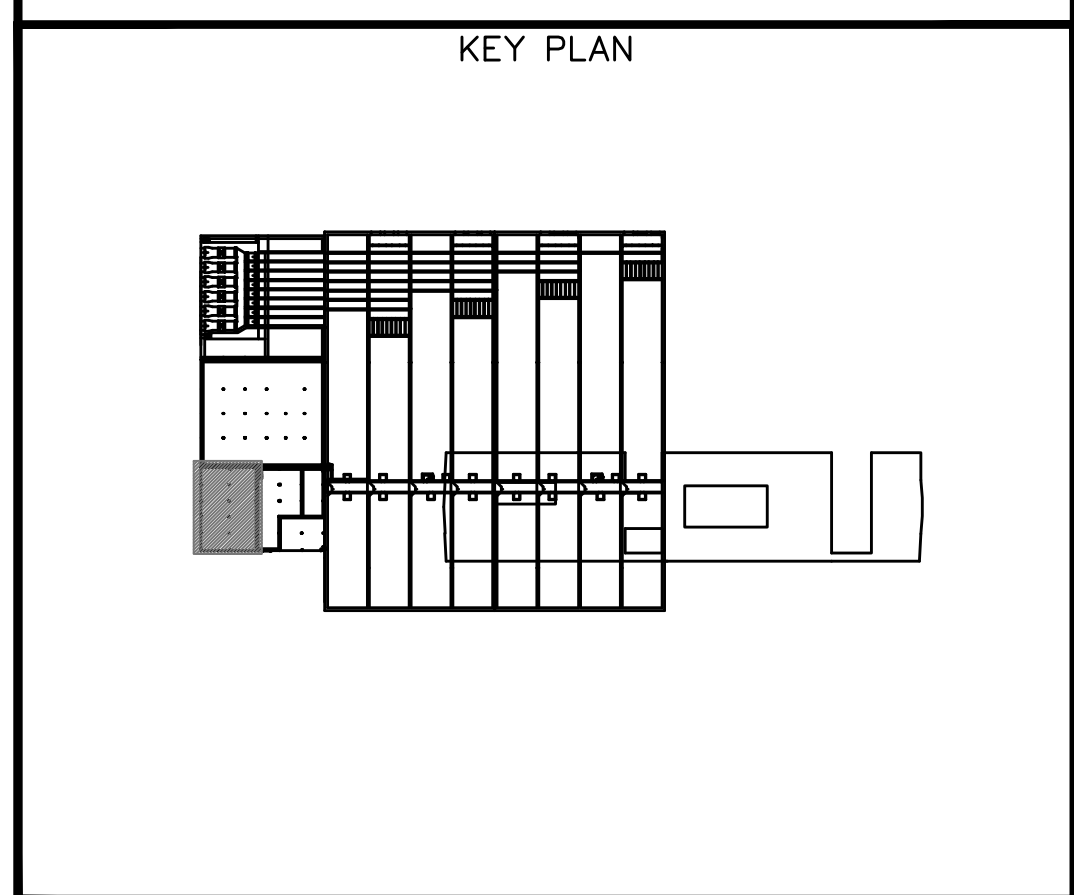

PROJECT NAME: WP-169 PAERDEGAT BASIN WATER QUALITY CONTRACT NO.: CSO-5P

ITEM	PLUMBING LAYOUT DRAWINGS
SPEC. SECTION	15050
PAGE/PARAGRAPH	NA
CONTRACT DRAWING	3P-P-PB004
LOCATION	PUMP BACK BUILDING
SUBMITTAL NUMBER	15150-006-A
REVIEW CYCLE NUMBER	001
DRAWING NUMBER	PB-P-01
APPROVED BY	-
DATE	2-06-06

RECORD DRAWING OF WORK ASBUILT
MARCH 2009

DAWG DRAFTING

SCALE: 3/16"=1'-0"	THIS DRAWING CREATED FROM CONTRACT DOCUMENTS DATED NOVEMBER 2004	FILE	REVISED:
DATE: 5/16/06			

CITY OF NEW YORK
DEPARTMENT OF ENVIRONMENTAL PROTECTION
BUREAU OF ENVIRONMENTAL ENGINEERING
DIVISION OF FACILITIES DESIGN
WP-169 CITY WIDE CSO FACILITIES
PAERDEGAT BASIN WATER QUALITY FACILITY
CONTRACT CSO-5P - STRUCTURES AND EQUIPMENT

PUMP BACK BUILDING

GROUND FLOOR PLUMBING PLAN	DRAWING NO. PB-P-01
----------------------------	-------------------------------