


Oct 31, 2006 - 9:17P D:\JOB\PARDEGAT BASIN\SHOP DRAWINGS\ODOR CONTROL\GROUND FLOOR-SP SW Layout.SPOOL 2, By: DAVID MARVIN

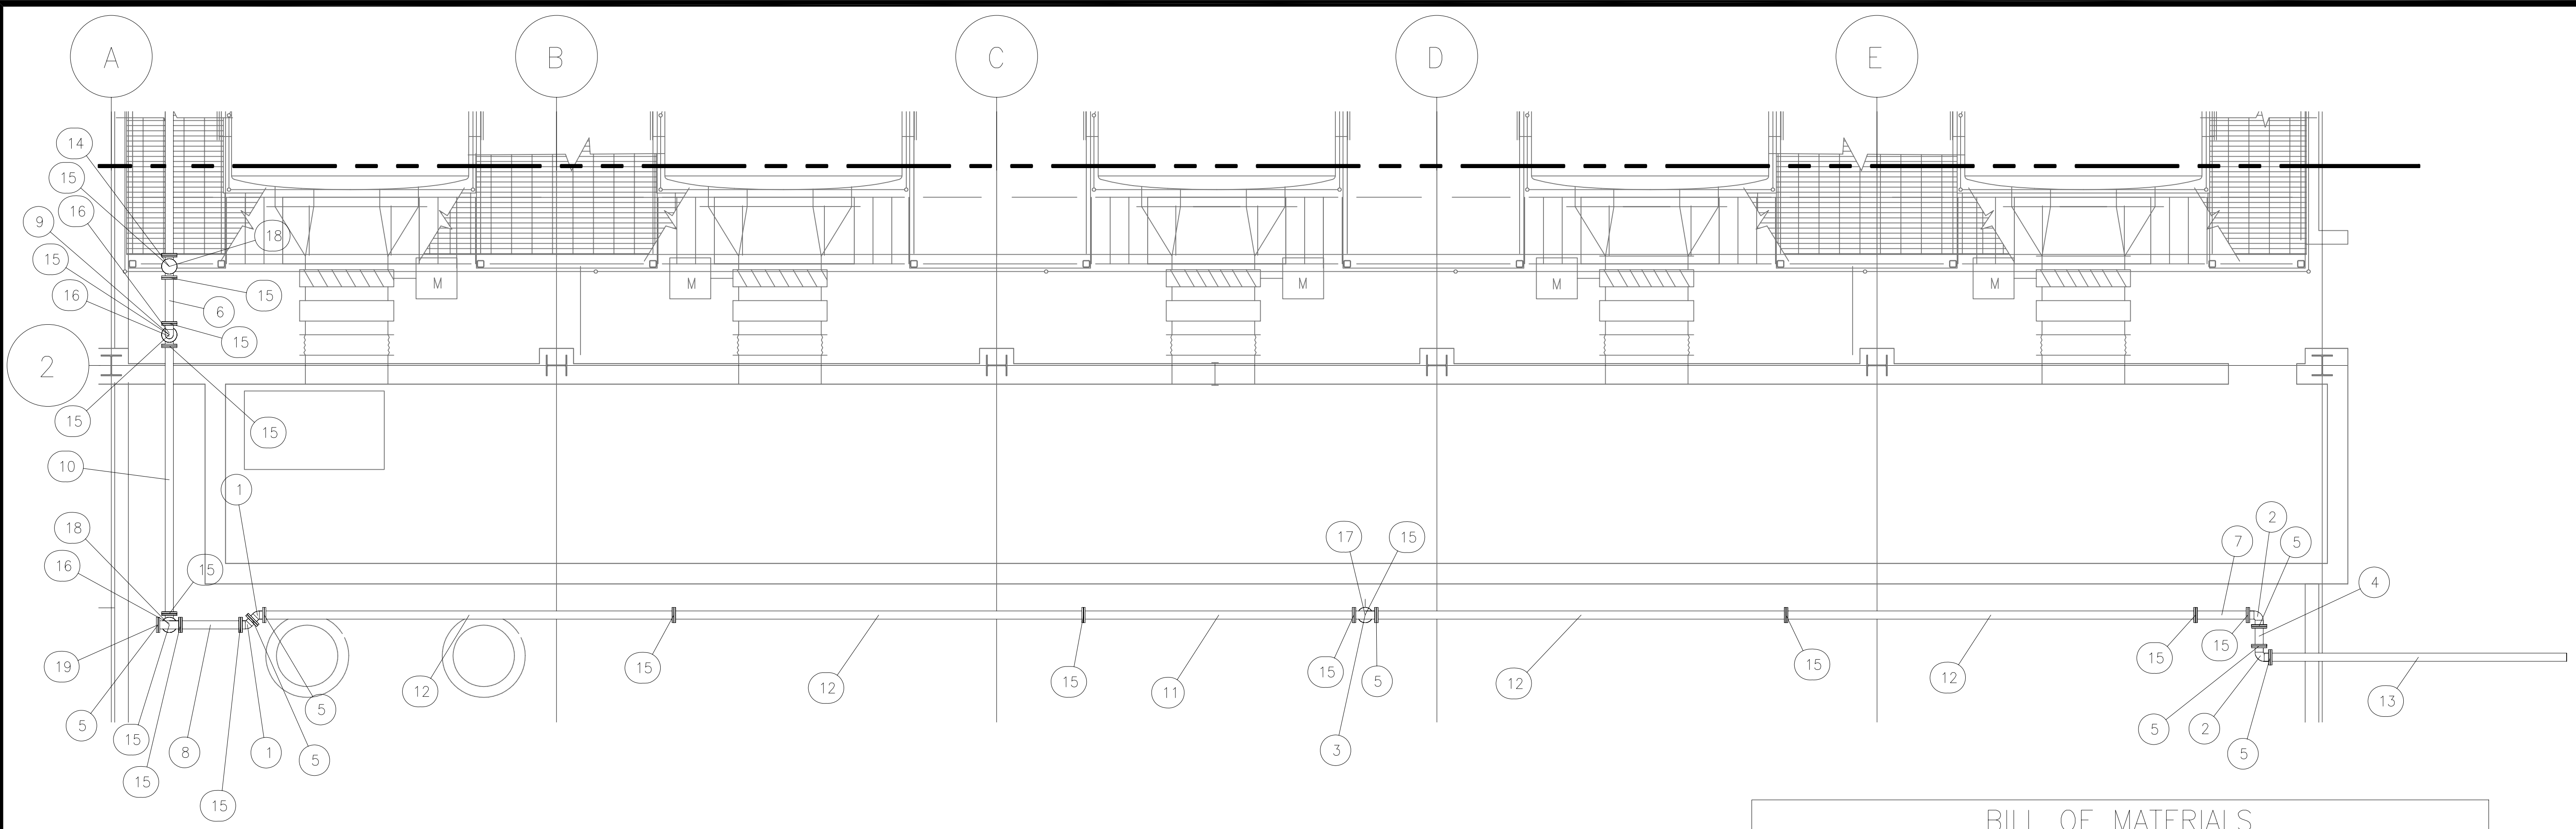


BILL OF MATERIALS				
Mark	Quantity	Size	Length	Long Description
1	2	4"		AWWA 45 DEG ELBOW
2	2	4"		AWWA 90 DEG ELBOW
3	1	4"		AWWA TEE
4	1	4"	11 1/2"	D.I. PIPE, CLASS 53 (FLG X FLG)
5	7	4"		GASKET AND MACHINE BOLT SET8@(5/8" X 3 1/4")
6	1	4"	2'-2 3/4"	D.I. PIPE, CLASS 53 (FLG X FLG)
7	1	4"	2'-6 1/2"	D.I. PIPE, CLASS 53 (FLG X FLG)
8	1	4"	2'-11 1/8"	D.I. PIPE, CLASS 53 (FLG X FLG)
9	1	4"	4'-2 13/16"	D.I. PIPE, CLASS 53 (FLG X FLG)
10	1	4"	13'-0 3/4"	D.I. PIPE, CLASS 53 (FLG X FLG)
11	1	4"	13'-2 3/8"	D.I. PIPE, CLASS 53 (FLG X FLG)
12	4	4"	20'-0"	D.I. PIPE, CLASS 53 (FLG X FLG)
13	1	4"	14'-5 5/8"	D.I. PIPE, CLASS 53 (GRV X FLG)
14	1	4"		AWWA BLIND FLANGE W/ 2" TAP
15	17	4"		GASKET AND MACHINE BOLT SET8@(5/8" X 3 1/4")
16	3	4"		AWWA 90 DEG ELBOW
17	1	4"		AWWA BLIND FLANGE W/ 1" TAP
18	2	4"		AWWA TEE
19	1	4"		VIC FLANGE ADAPTER STYLE 341

REVISIONS			
ZONE	REV	DESCRIPTION	DATE
	1	SW BOM	10/31/06

SCALE
1/4"=1'

KEY PLAN

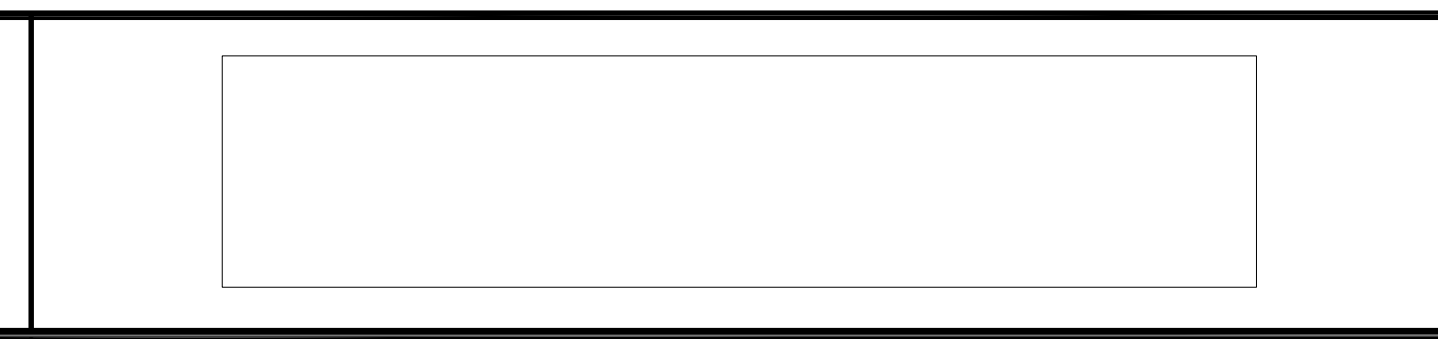

CITY OF NEW YORK
DEPARTMENT OF ENVIRONMENTAL PROTECTION
BUREAU OF ENVIRONMENTAL ENGINEERING
WP-168 WATER QUALITY FACILITY
CONTRACT 5G
BOROUGH OF BROOKLYN

PROJECT NAME: WP-168 Pierdegat Basin CSO
CONTRACT NO.: CSO-5G
CONTRACTOR NAME: SSI/GSI

DATE: _____
DESIGNER: _____
CHECKED: _____
CONTRACT DRAWING NO.: _____
LOCATION: _____
SUBMITTAL NO.: _____
WORKING DRAWING REFERENCE NO.: _____
SOURCE COMPANY NAME: _____
APPROVED BY: _____

ODOR CONTROL BUILDING
SERVICE WATER SPOOL SHEET
GROUND FLOOR

DES. SSI/GSI
DWN. DM

CHD. KC
DATE 6/30/06

DWG. NO. PB-08-02-SP BOM

SHEET 2 of 2